


EXISTING LIGHT FIXTURE SCHEDULE								
Symbol	Label	Catalog Number	Description	Number Lamps	Filename	Lumens Per Lamp	Light Loss Factor	Wattage
	A	VILLA LIGHTING-KGBM-FT-LED-HO-NW-HSS	CONTACT RYAN ZINSELMEIER- 314-531-2600	1	XGBM-FT-LED-HO-NW-HSS.lss	17359.93	1	288.8
	B	VILLA LIGHTING-KGBM-S-LED-HO-NW-HSS	CONTACT RYAN ZINSELMEIER- 314-531-2600	1	XGBM-S-LED-HO-NW-HSS.lss	14079.29	1	288.3

ELECTRICAL NOTES BY SYMBOL "◇"

- ◇1
- LIGHT FIXTURE/SIGN OUTSIDE OF SCOPE.
- ◇2
- LIGHT FIXTURES ARE EXISTING.

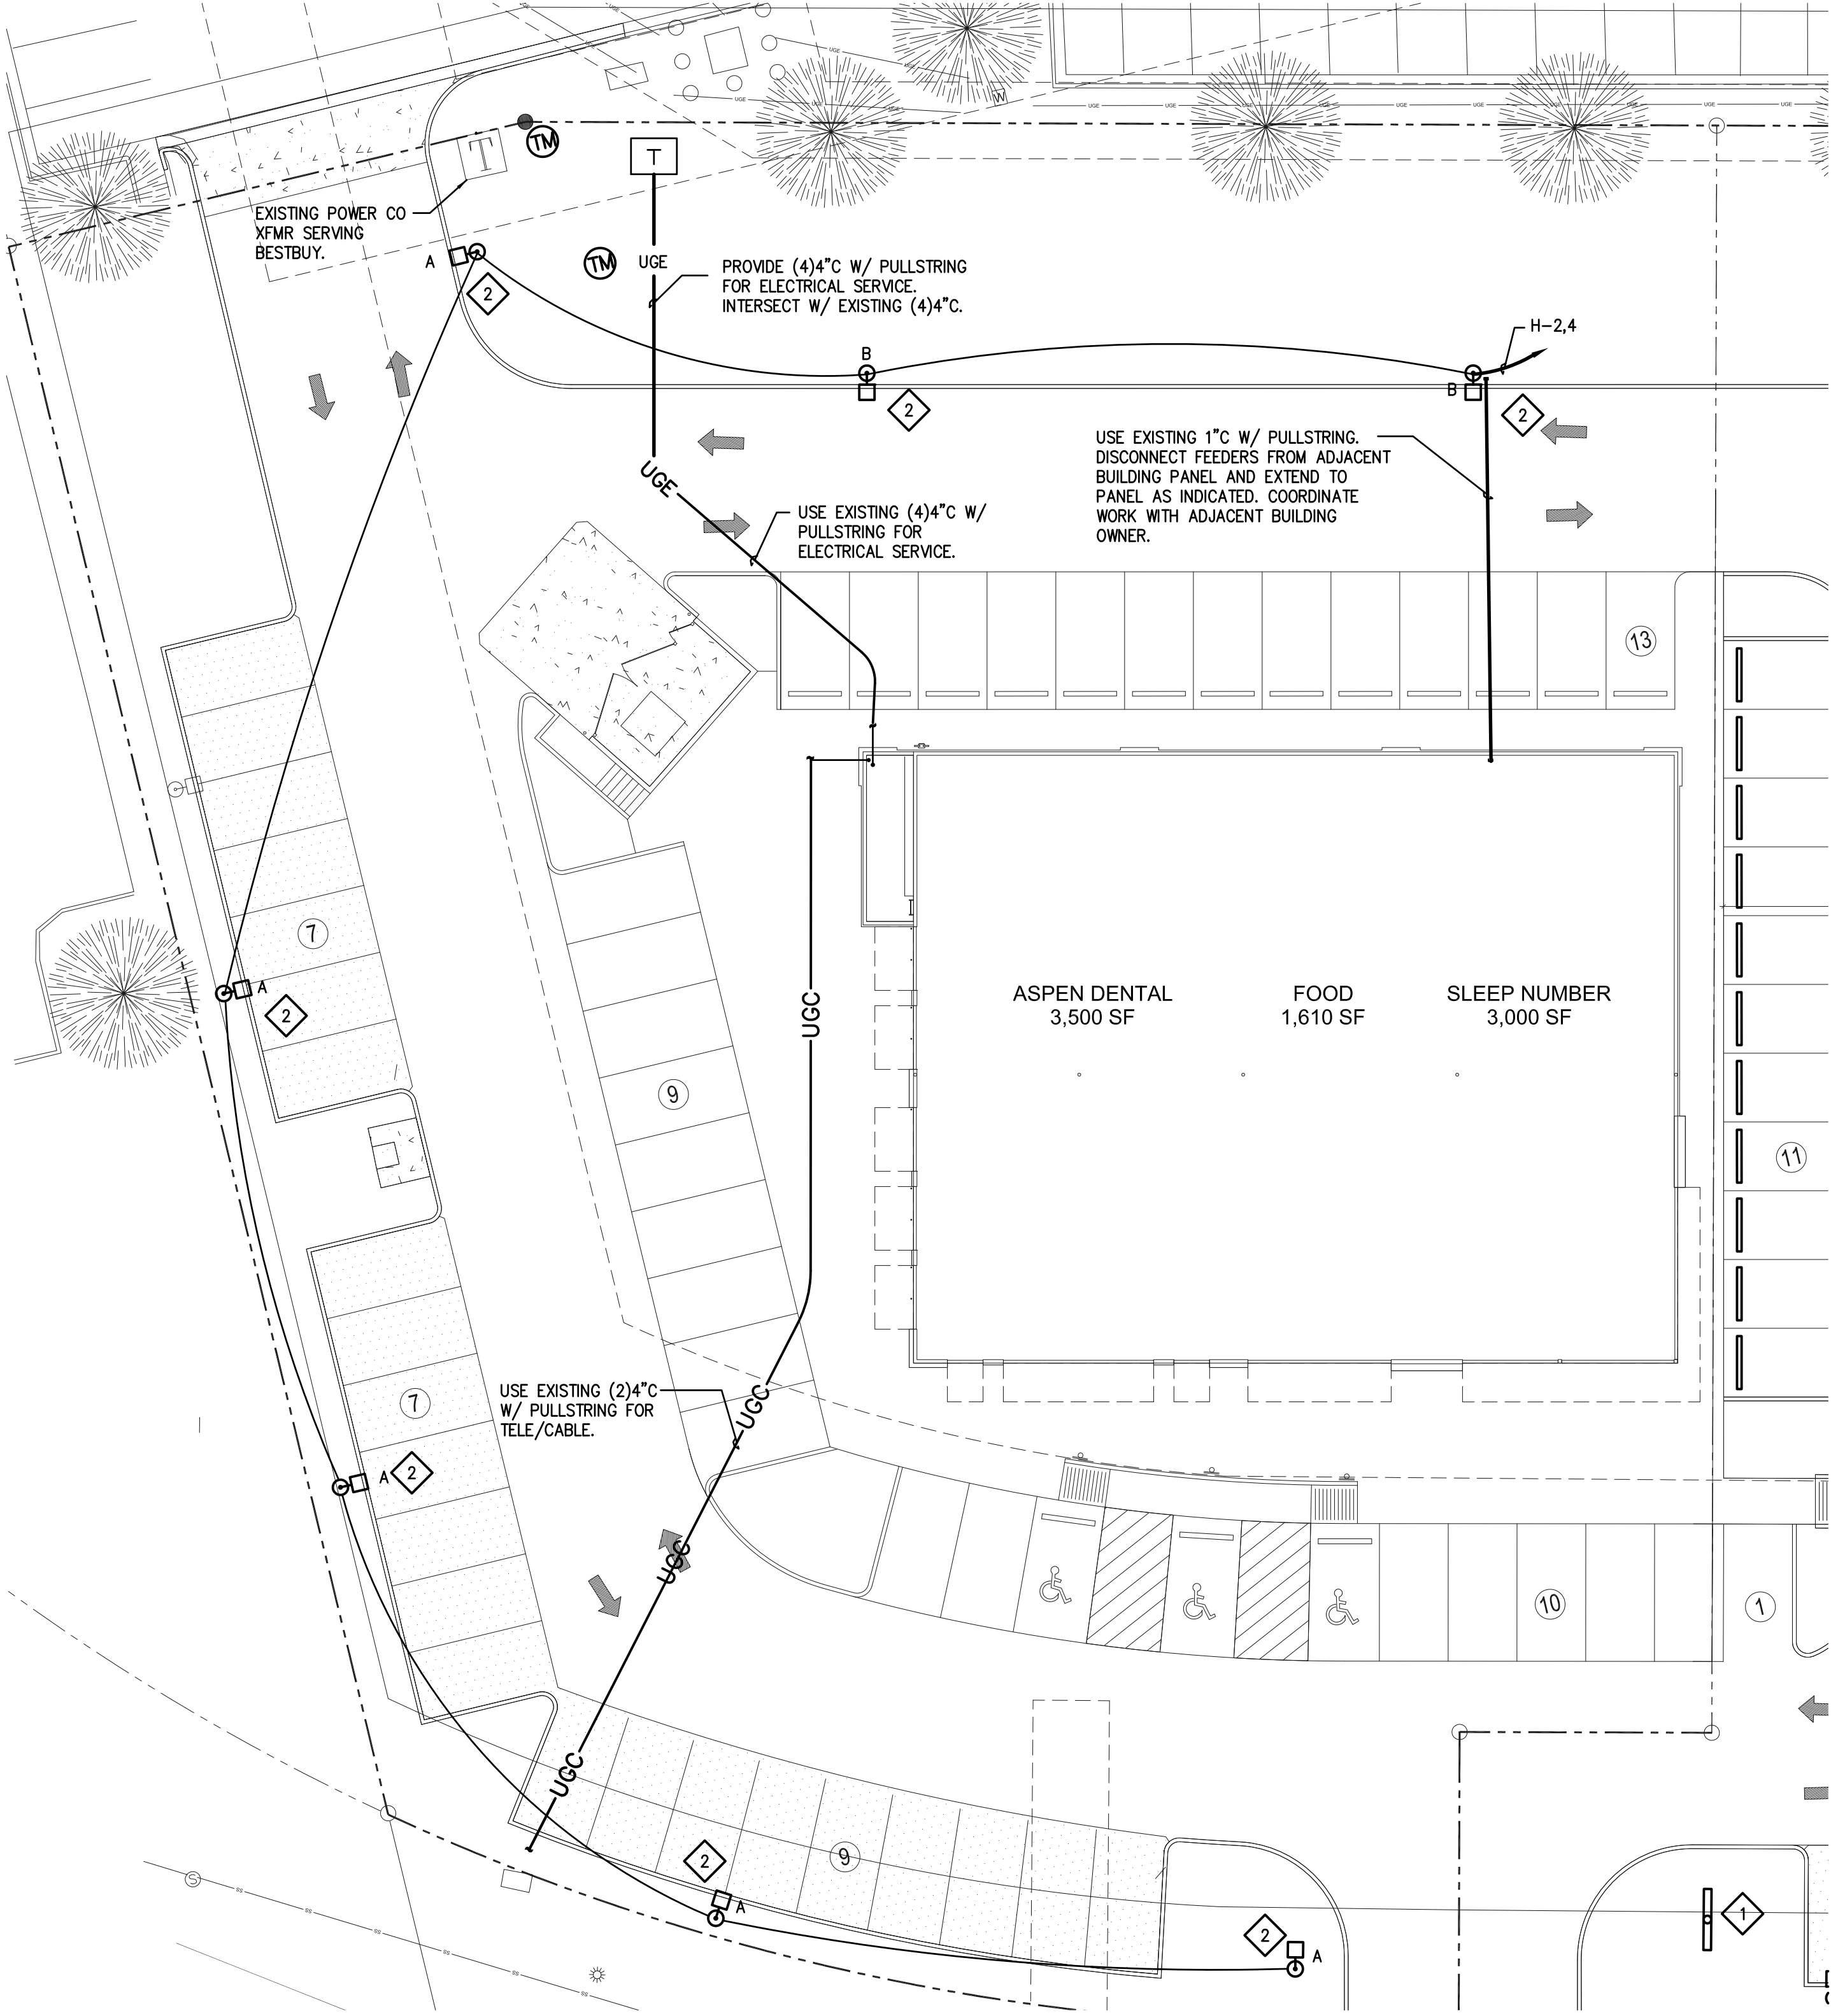

1 ELECTRICAL SITE PLAN

SCALE: 1"=16'-0"

CLIENT LOGO:



CFT DEVELOPMENT, LLC.

1683 Walnut Grove Ave.  
Rosemead, California  
91770

Telephone: 626.799.9898

Facsimile: 626.372.8288

All ideas, designs, arrangement and plans indicated or represented by this drawing are the property of CFT, and were created for use on this specific project. None of these ideas, designs, arrangements or plans may be used by or disclosed to any person, firm, or corporation without the written permission of CFT.

REVISIONS:

NO.	DESCRIPTION	DATE

ISSUE DATE:

1 PERMIT/BID SET 06.04.18


Heights Venture  
ARCHITECTURE • DESIGN

HOUSTON 1111 North Loop West, Suite 800 Houston, Texas 77008 713 869 1103 V  
DALLAS 5717 Legacy Drive, Suite 240 Plano, Texas 75024 972 450 7292 V

James F. Turner  
Engineers, L.P.  
Consulting Engineers  
8340 Meadow Road, #160  
Dallas, TX 75237  
214.750.2900  
DRAWN/DESIGN: QNT  
CCT/APP: JNM  
JNT #42821  
LA #17E, COA #4909



CFT - MONROE

4401 PECANLAND MALL  
DR MONROE, LA 71203

CFT PROJECT #: CT  
ARCH PROJECT #: 00001-001-000

E0.1  
ELECTRICAL  
SITE PLAN